



All ideas, designs, arrangement and plans indicated or represented by this drawing are the property of Panda Express Inc. and were created for use on this specific project. None of these ideas, designs, arrangements or plans may be used by or disclosed to any person, firm, or corporation without the written permission of Panda Express Inc.

REVISIONS

[illegible]

 
ISSUE DATE:

1st	ISSUE FOR PERMIT	02-15-1
2nd	ISSUE FOR BID	02-22-1

DRAWN BY:

PANDA PROJECT #: S8-17-D4968
ARCH PROJECT #: 1703

Project No.
PE1703






PANDA EXPRESS
Terrence at Suwanee Gateway (in front of Lowe's)
3276 LAWRENCEVILLE-SUWANEE RD
SUWANEE, GA

2200 TRUE WARM & WELCOME

E-401


ELECTRICAL DETAILS, DIAGRAMS

TRUE WARM & WELCOME 2200

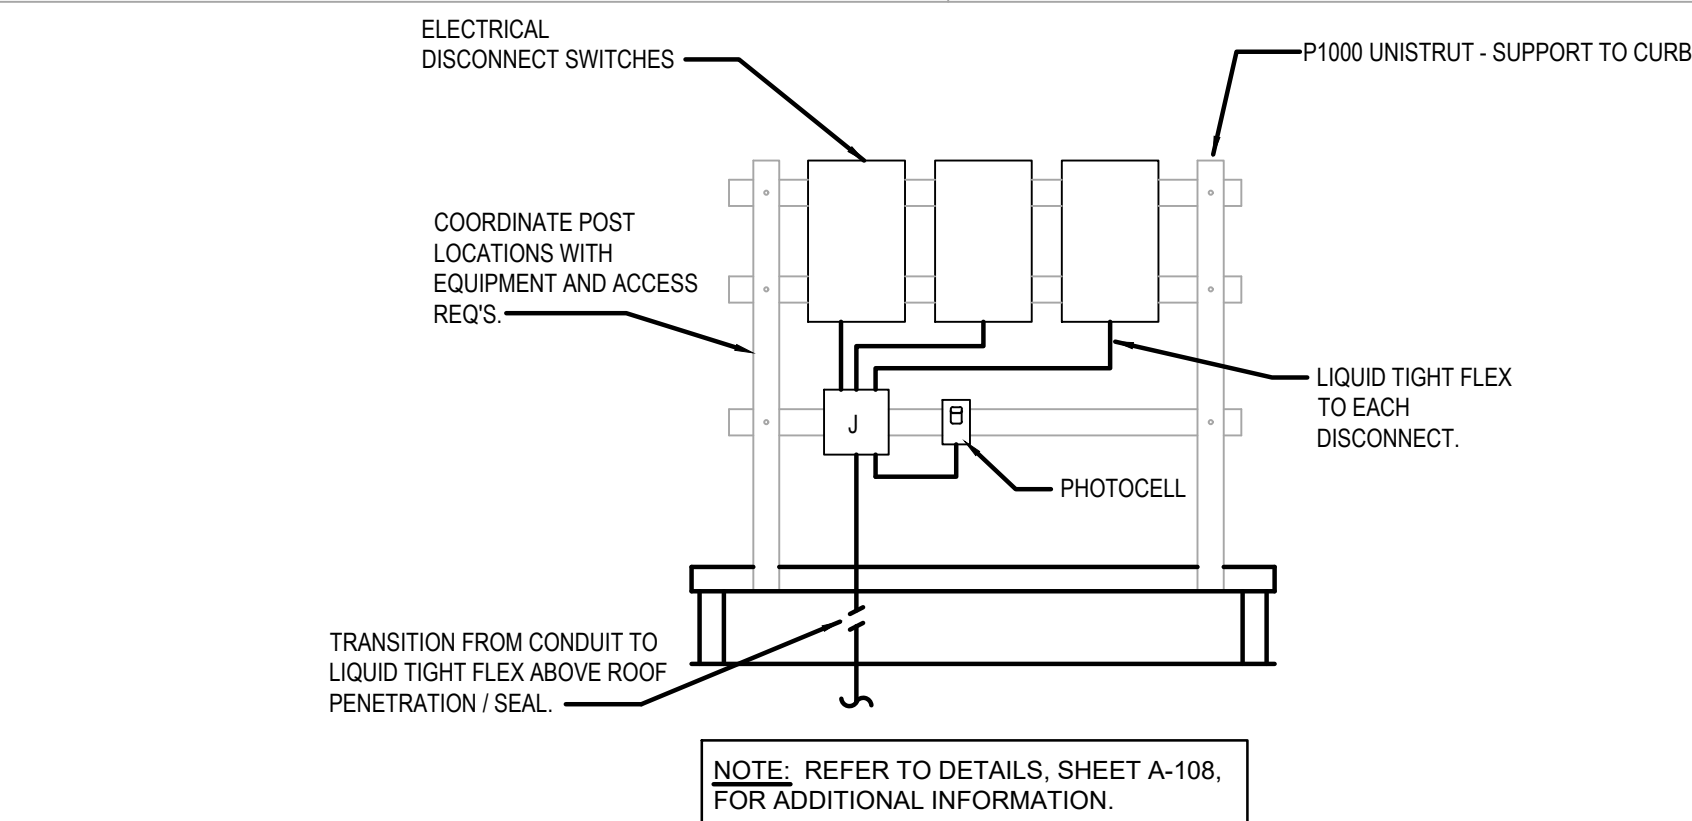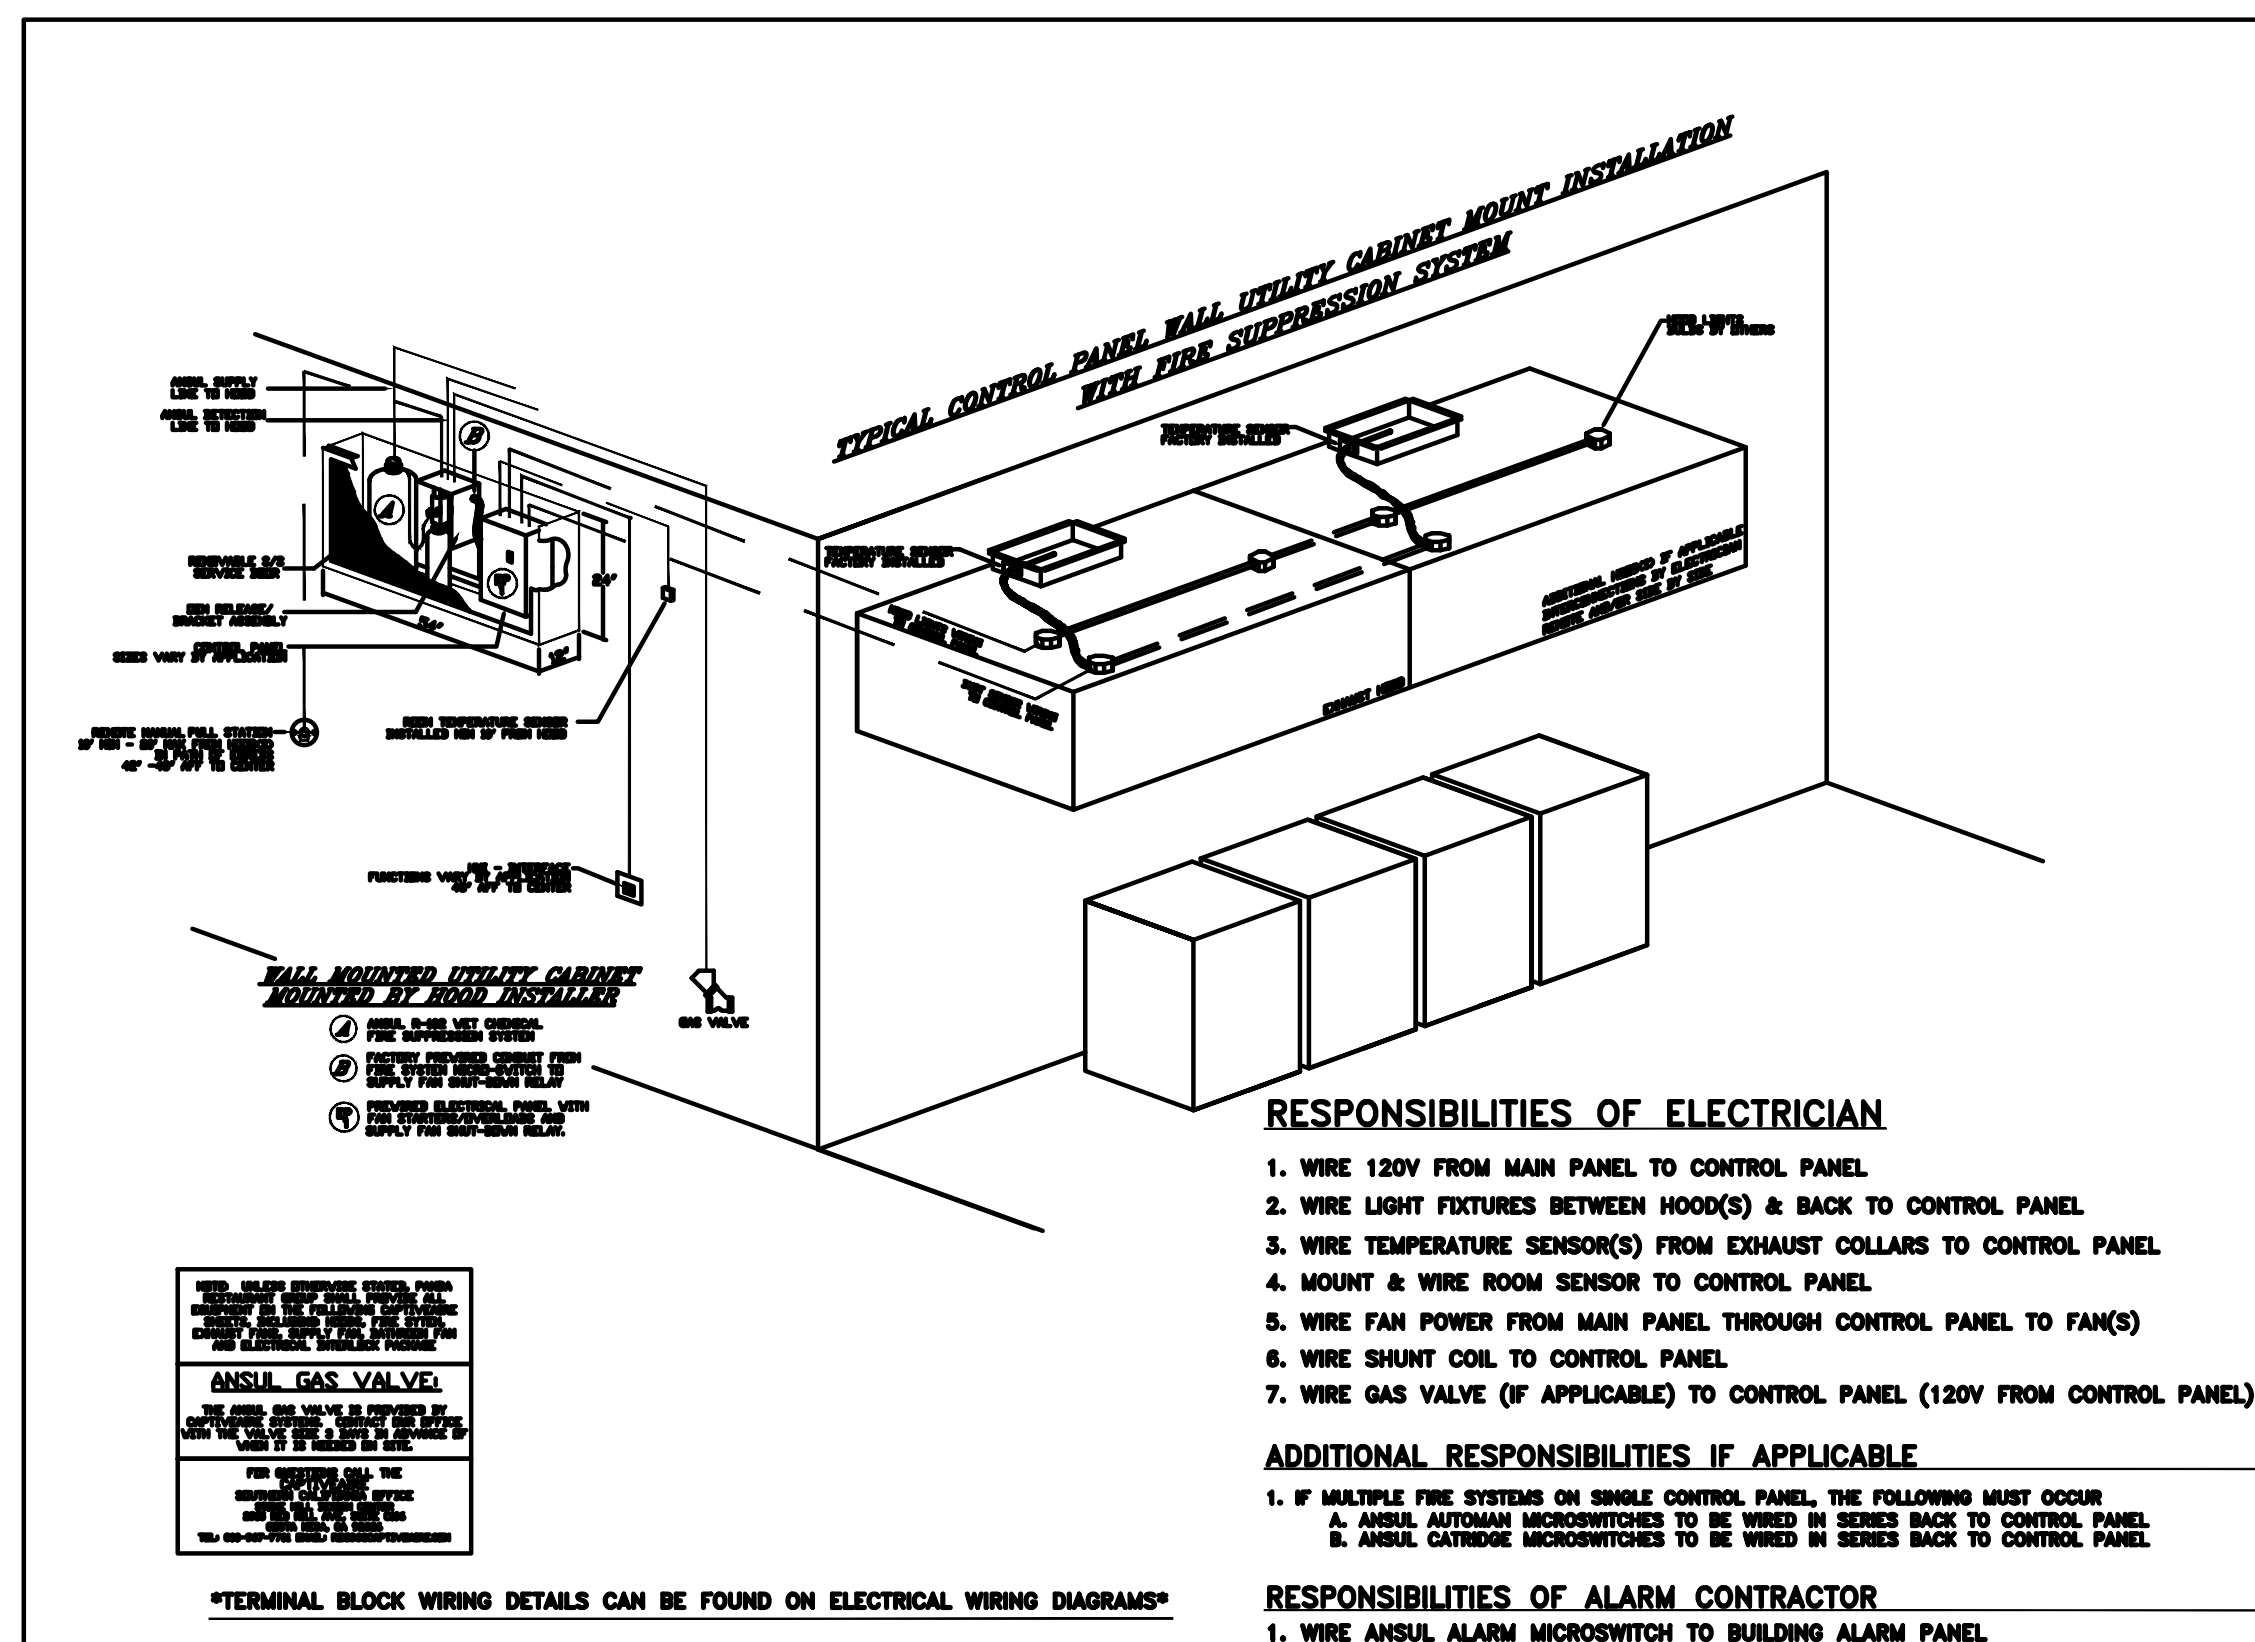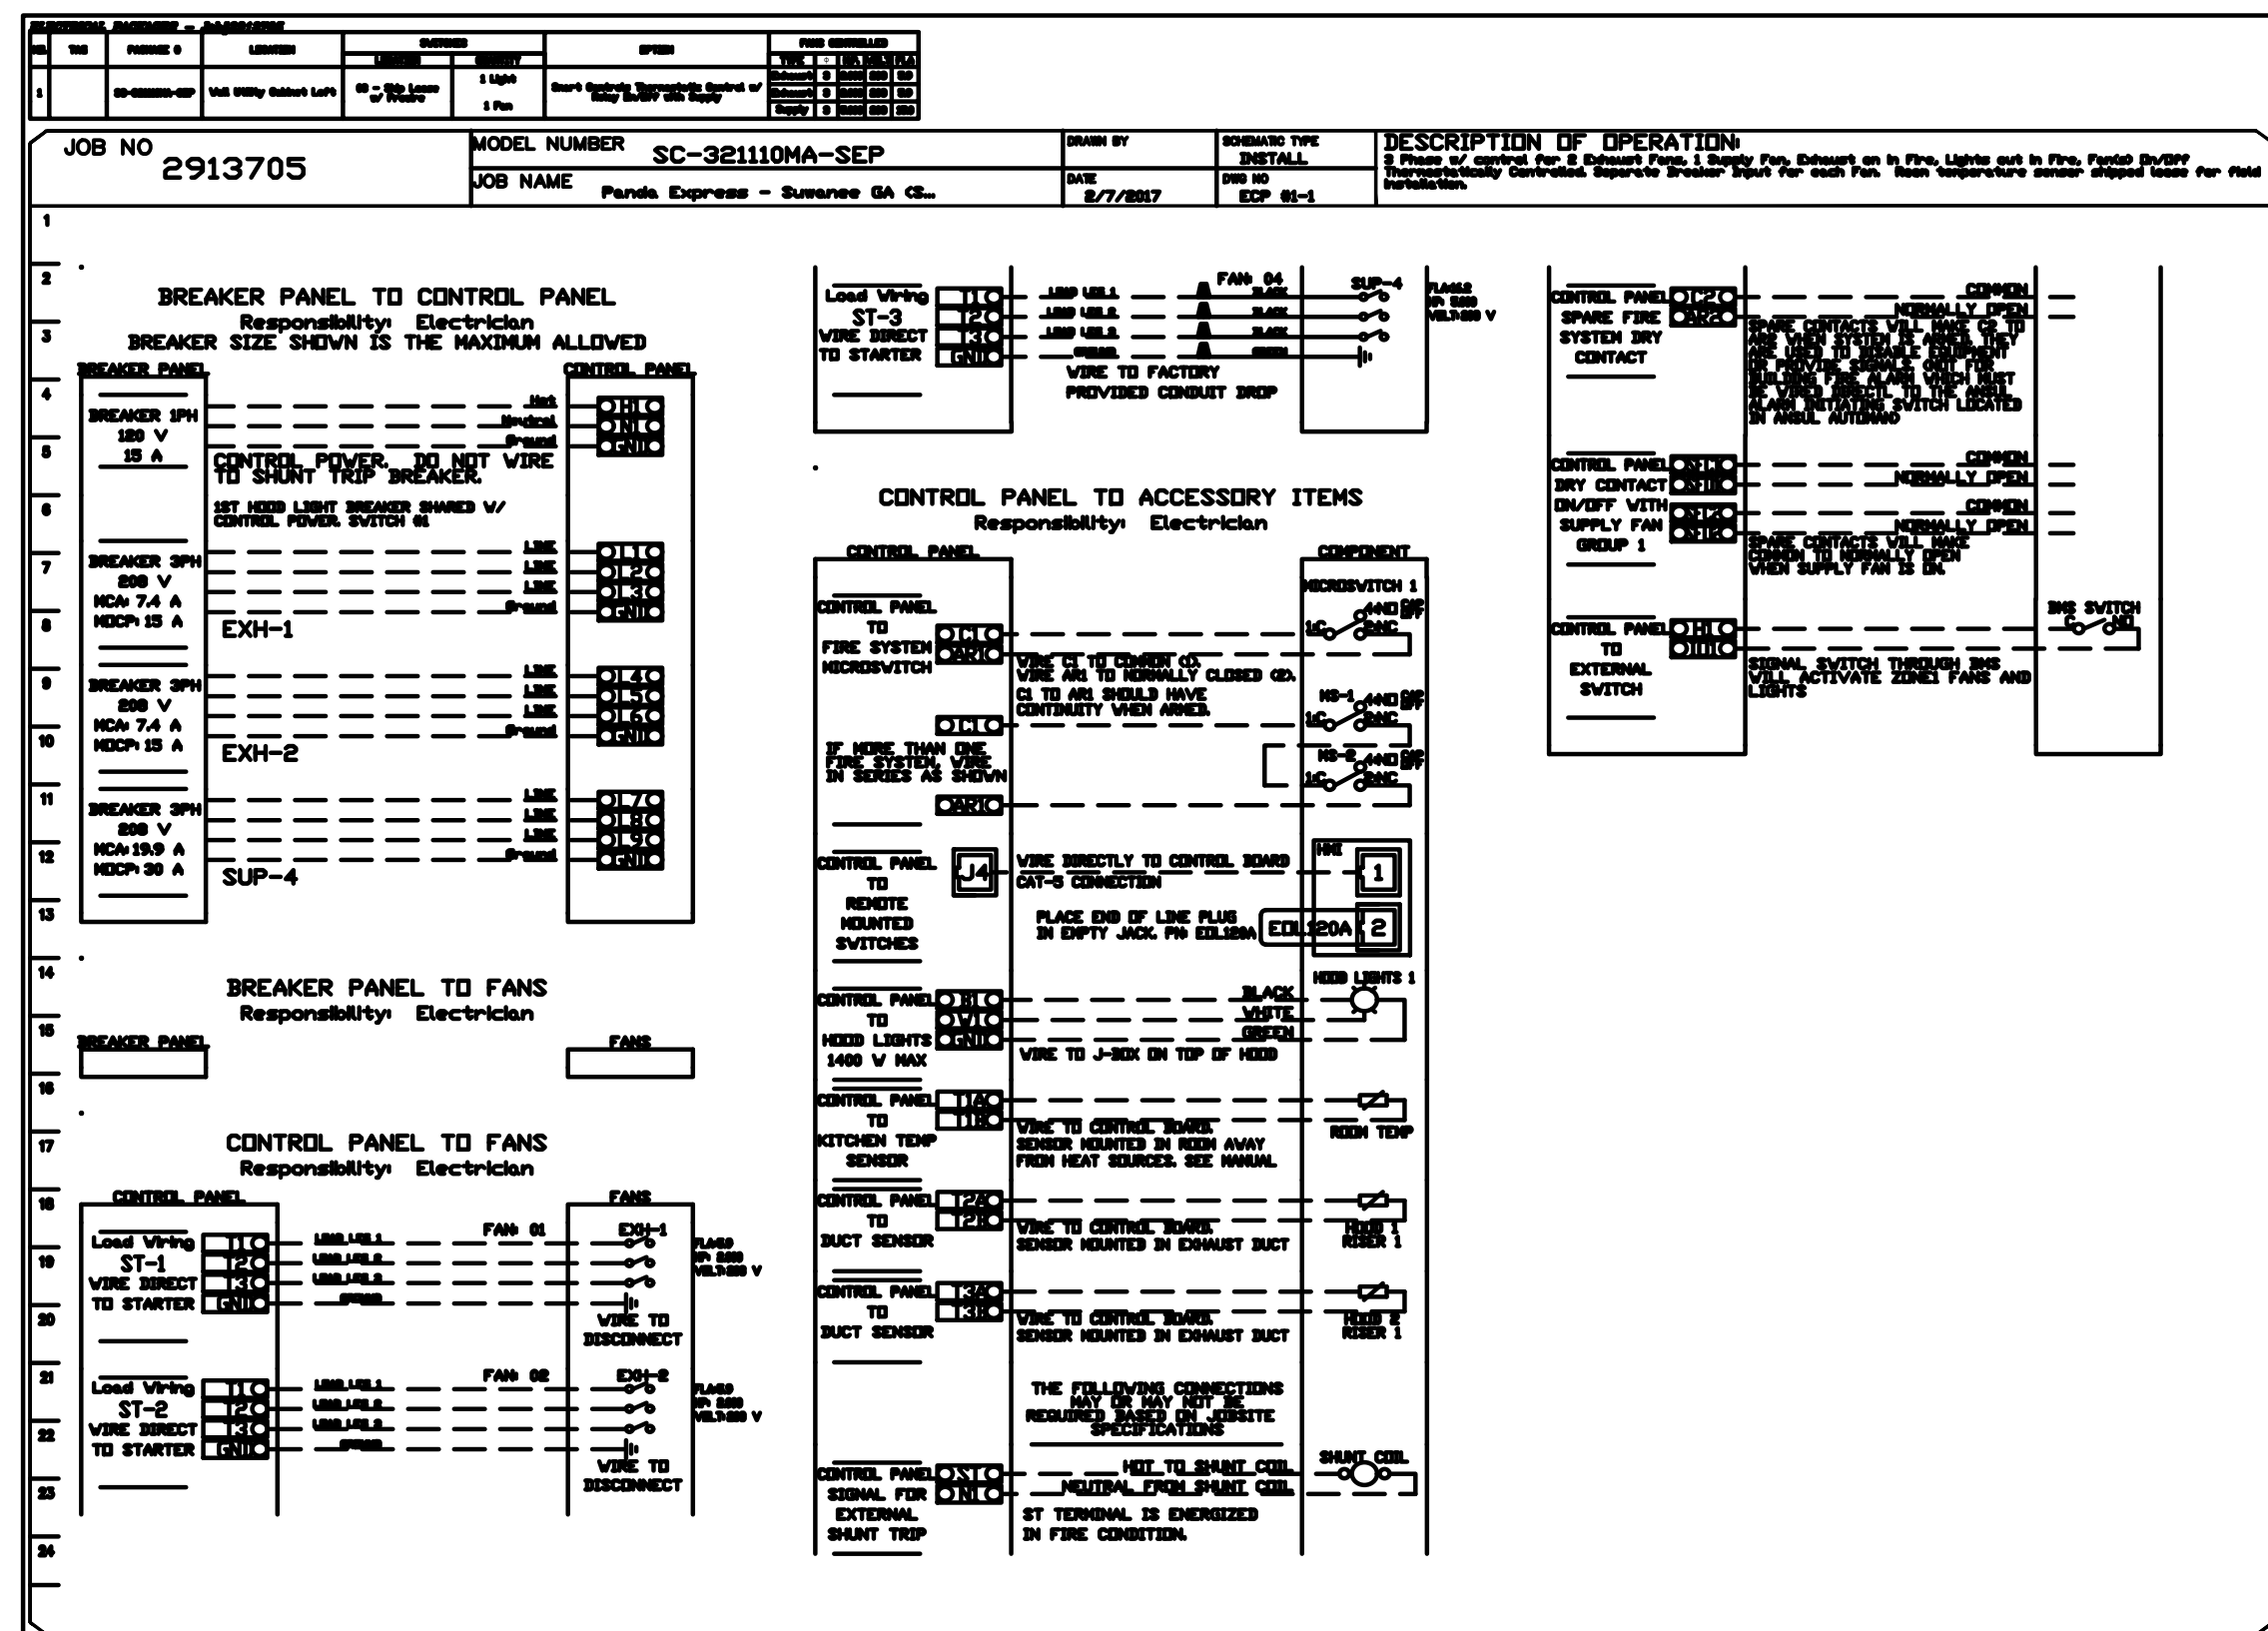

EQUIPMENT DISCONNECT SWITCH SUPPORT	2
-------------------------------------	---

NOT TO SCALE | E-40'

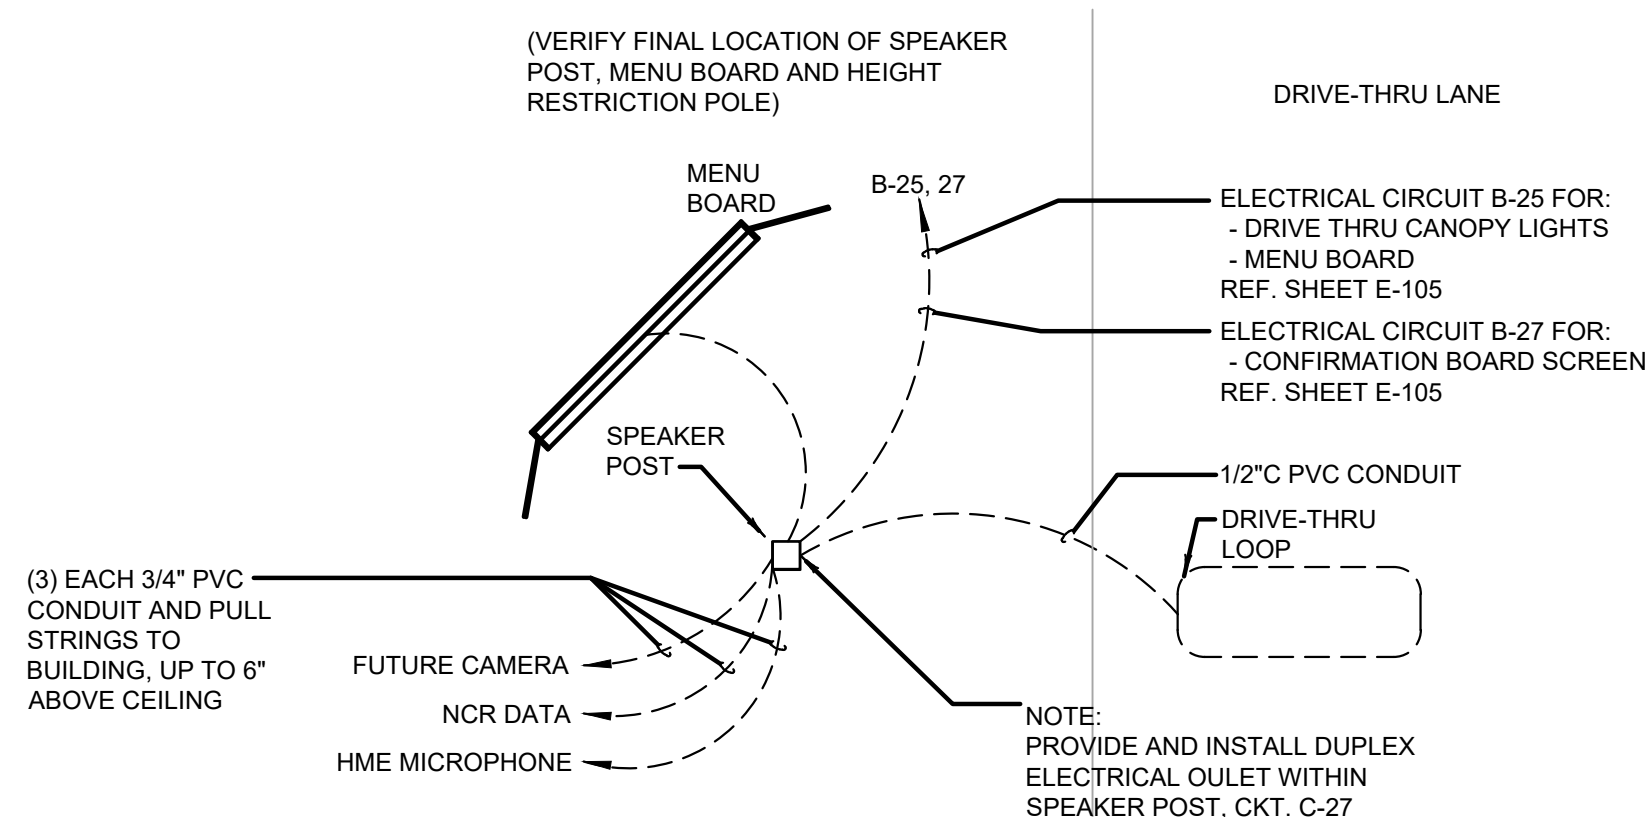

MENU BOARD & SENSOR LOOP	1
--------------------------	---